


FIRST FLOOR PLAN - PART 6 - HVAC HANGERS

SCALE: 1/4" = 1'-0"

No.	Date	Description

NSU Classroom & Nursing Bldg
NORFOLK, VIRGINIA
FIRST FLOOR PLAN - PART 6 - HVAC HANGERS

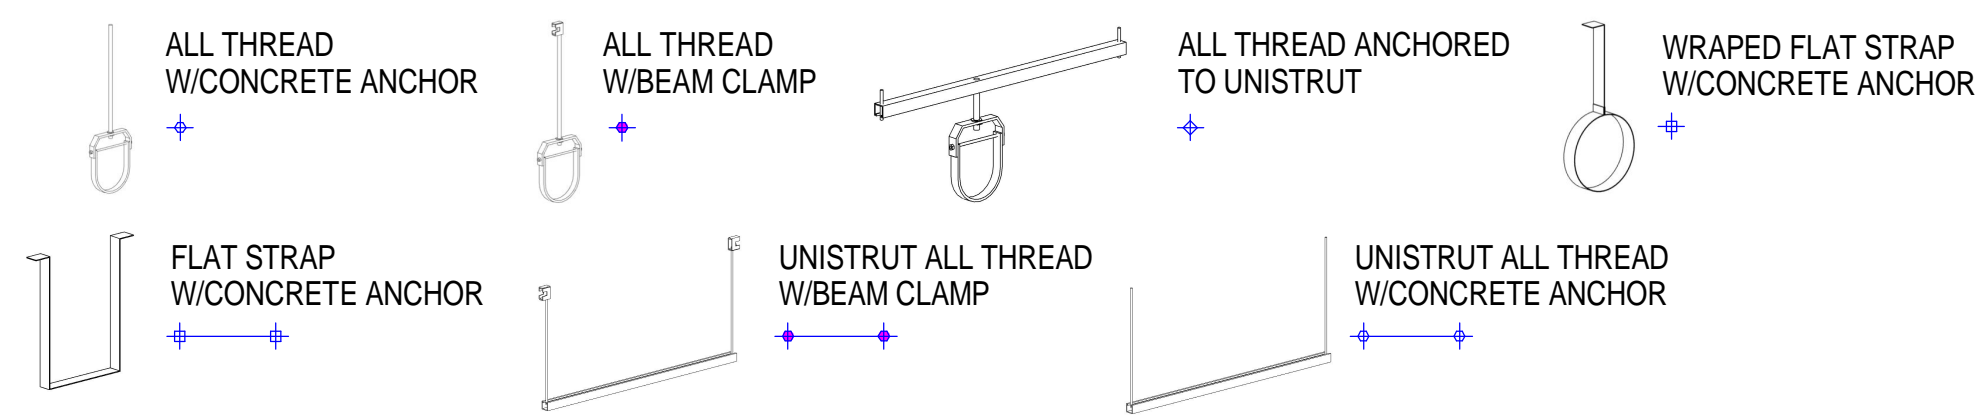

GRAPHIC SCALES

